

UNIVERSITY of
CHESTER

DRAWN BY
 KEVIN KEENE
 DATE DRAWN
 06-06-11

PROJECT NAME
 SIGMA HOUSE


DRAWING NAME
 FIRST FLOOR PLAN

DRAWING NUMBER
 099

DRAWING SCALE
 1:50

BUILDING NUMBER
 099

CAMPUS
 SPACE

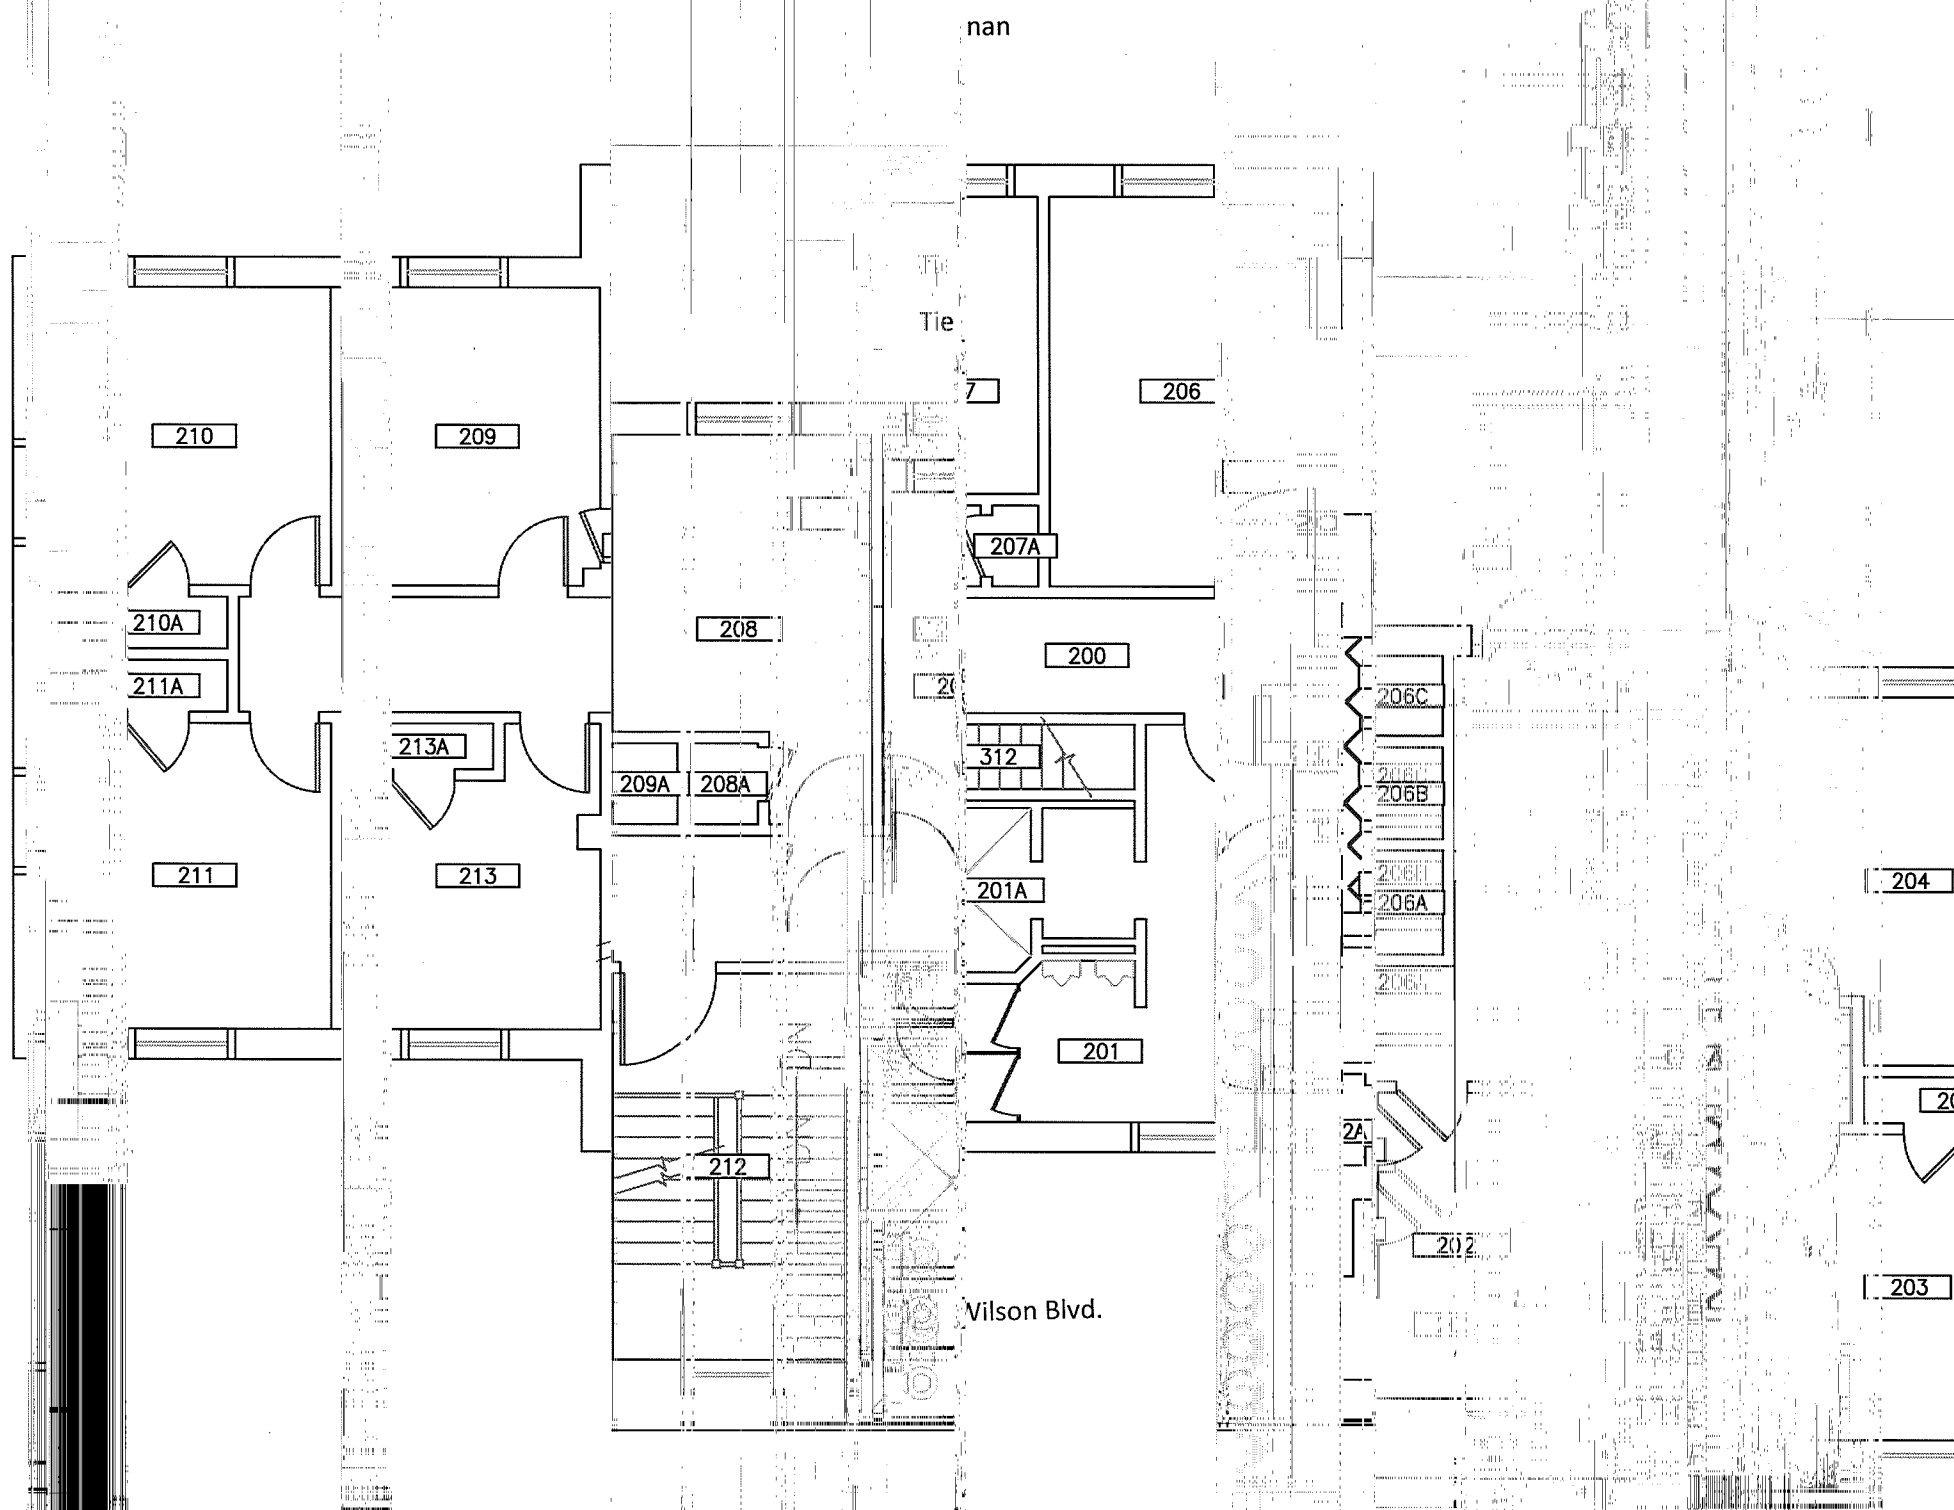

nan

Tie

7

206

210

209

210A

211A

208

207

200

206C

206B

206A

206

204

211

213

213A

209A

208A

312

201A

201

206

20

212


2A

202

203

Wilson Blvd.

Tiernan

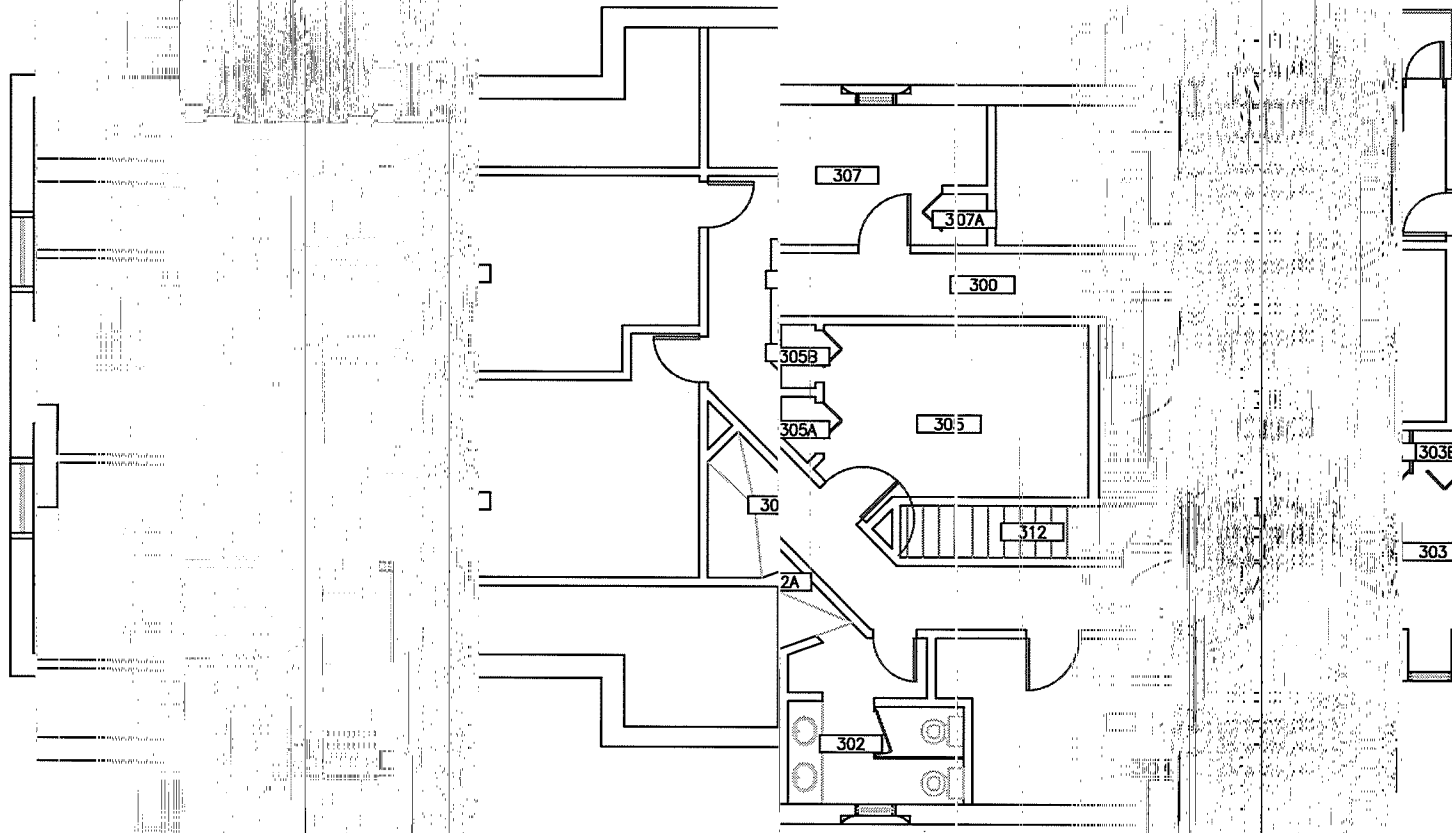

Wilson Blvd.

UNIVERSITY of
ROCHESTER

DRAW
KEY

DATE

06-

DRAWN OR REVISED BY:
N KEHOE

DATE DRAWN OR REVISED:
06-11

DRAWING NAME:
THIRD FLOOR PLAN

DRAWING SCALE:
3/32" = 1'-0"

DRAW
P/SP

CAMP

4 LEAR

DESIGN